


ELECTRICAL SYMBOL LIST (NOTE: SOME SYMBOLS AND ABBREVIATIONS SHOWN MAY NOT APPLY TO THIS PROJECT)

SYMBOL	DESCRIPTION	SYMBOL	DESCRIPTION	SYMBOL	DESCRIPTION	SYMBOL	DESCRIPTION
NL/EM	DENOTES NIGHT LIGHT AND/OR EMERGENCY LIGHT	TWC	TWO-WAY COMMUNICATION SYSTEM CALL STATION	CP	CONTROL PANEL	FC	SECURITY CAMERA
X	DENOTES FIXTURE TYPE	TWD	TWO-WAY COMMUNICATION SYSTEM AUTO DIALER	MC	MOTOR	SD	MOTION DETECTOR
Z	DENOTES LIGHTING CONTROL ZONE	TWCA	TWO-WAY COMMUNICATION SYSTEM ANNUNCIATOR & COMMUNICATION PANEL	VFC	VARIABLE FREQUENCY CONTROLLER	DO	SECURITY KEY SWITCH
ZZ-#	DENOTES PANELBOARD AND BREAKER	TWCP	TWO-WAY COMMUNICATION SYSTEM POWER SUPPLY WITH BATTERY BACK-UP	MC	MANUAL CONTROLLER	CO	DOOR CONTACT
EM	FILL DENOTES EMERGENCY FIXTURE	TWCPD	TWO-WAY COMMUNICATION SYSTEM AUTO DIALER POWER SUPPLY WITH BATTERY BACK-UP	MC	MAGNETIC CONTROLLER	RT	REMOTE TEST STATION (FOR DUCT DETECTOR)
TL	TROFFER LIGHT	RGP	REMOTE GENERATOR ANNUNCIATOR PANEL	DB	COMBINATION MAGNETIC CONTROLLER	HD	HEAT DETECTOR
SL	STRIP LIGHT	ATS	AUTOMATIC TRANSFER SWITCH	NS	NON-FUSIBLE DISCONNECT SWITCH	BD	PROJECTED BAY DETECTOR
LL	LINEAR LIGHT	UPS	UNINTERRUPTIBLE POWER SUPPLY	FS	FUSIBLE DISCONNECT SWITCH	FB	FIRE ALARM BELL
MA	MULTIHEAD ADJUSTABLE LIGHT	AC	SINGLE / DUPLEX RECEPTACLE OUTLET "X" INDICATES TYPE	EN	ENCLOSED CIRCUIT BREAKER	FN	FIRE ALARM AUDIBLE NOTIFICATION APPLIANCE
DL	DOWN LIGHT	ACD	SINGLE/DUPLEX RECEPTACLE OUTLET CONTROLLED BY AUTOMATIC CONTROL DEVICE/SYSTEM (SIMILAR FOR TAMPER RESISTANT, GFCI, USB)	PS	PUSH BUTTON STATION	FX	FIRE ALARM VISUAL NOTIFICATION APPLIANCE "XX" INDICATES CANDELA RATING IF NO RATING SHOWN, APPLIANCE IS 15cd
DD	DIRECTIONAL DOWN LIGHT	ACD	DUPLEX / TAMPER RESISTANT RECEPTACLE OUTLET HALF CONTROLLED BY AUTOMATIC CONTROL DEVICE/SYSTEM	JB	JUNCTION BOX	FX	FIRE ALARM COMBINATION VISUAL / AUDIBLE "XX" INDICATES CANDELA RATING IF NO RATING SHOWN, APPLIANCE IS 15cd
DL	DECORATIVE LIGHT	ACD	QUAD RECEPTACLE OUTLET	HC	HANDHOLE	FX	FIRE ALARM VISUAL NOTIFICATION APPLIANCE - CEILING MOUNTED "XX" INDICATES CANDELA RATING IF NO RATING SHOWN, APPLIANCE IS 15cd
DL	DECORATIVE LIGHT	ACD	ABOVE COUNTER DUPLEX RECEPTACLE OUTLET (SIMILAR FOR TAMPER RESISTANT, CONTROLLED, SINGLE, QUADS, EMERGENCY, UPS, USB, AND GFCI RECEPTACLE OUTLETS)	HS	CONDUIT SLEEVE WITH BUSHINGS LENGTH AS REQUIRED "X" INDICATES CONDUIT SIZE	FX	FIRE ALARM VISUAL NOTIFICATION APPLIANCE - CEILING MOUNTED "XX" INDICATES CANDELA RATING IF NO RATING SHOWN, APPLIANCE IS 15cd
DL	DECORATIVE LIGHT	ACD	DUPLEX GROUND FAULT CIRCUIT INTERRUPTER RECEPTACLE OUTLET	HC	CONDUIT UP	FX	FIRE ALARM VISUAL NOTIFICATION APPLIANCE - CEILING MOUNTED "XX" INDICATES CANDELA RATING IF NO RATING SHOWN, APPLIANCE IS 15cd
DL	DECORATIVE LIGHT	ACD	DEAD FRONT GROUND FAULT CIRCUIT INTERRUPTER	HC	CONDUIT DOWN	FX	FIRE ALARM VISUAL NOTIFICATION APPLIANCE - CEILING MOUNTED "XX" INDICATES CANDELA RATING IF NO RATING SHOWN, APPLIANCE IS 15cd
DL	DECORATIVE LIGHT	ACD	DUPLEX EMERGENCY RECEPTACLE OUTLET	HC	EMPTY BOX FOR FUTURE TELECOMMUNICATION OUTLET	FX	FIRE ALARM VISUAL NOTIFICATION APPLIANCE - CEILING MOUNTED "XX" INDICATES CANDELA RATING IF NO RATING SHOWN, APPLIANCE IS 15cd
DL	DECORATIVE LIGHT	ACD	DUPLEX TAMPER RESISTANT RECEPTACLE OUTLET	HC	EMPTY BOX FOR FUTURE CEILING MOUNTED TELECOMMUNICATION OUTLET	FX	FIRE ALARM VISUAL NOTIFICATION APPLIANCE - CEILING MOUNTED "XX" INDICATES CANDELA RATING IF NO RATING SHOWN, APPLIANCE IS 15cd
DL	DECORATIVE LIGHT	ACD	QUAD TAMPER RESISTANT RECEPTACLE OUTLET	HC	TELECOMMUNICATION OUTLET "X" INDICATES TYPE	FX	FIRE ALARM VISUAL NOTIFICATION APPLIANCE - CEILING MOUNTED "XX" INDICATES CANDELA RATING IF NO RATING SHOWN, APPLIANCE IS 15cd
DL	DECORATIVE LIGHT	ACD	DUPLEX UPS RECEPTACLE OUTLET	HC	ABOVE COUNTER TELECOMMUNICATION OUTLET "X" INDICATES TYPE	FX	FIRE ALARM VISUAL NOTIFICATION APPLIANCE - CEILING MOUNTED "XX" INDICATES CANDELA RATING IF NO RATING SHOWN, APPLIANCE IS 15cd
DL	DECORATIVE LIGHT	ACD	DUPLEX RECEPTACLE OUTLET WITH 2 USB PORTS	HC	EMPTY BOX FOR FUTURE TELECOMMUNICATION OUTLET	FX	FIRE ALARM VISUAL NOTIFICATION APPLIANCE - CEILING MOUNTED "XX" INDICATES CANDELA RATING IF NO RATING SHOWN, APPLIANCE IS 15cd
DL	DECORATIVE LIGHT	ACD	4 PORT USB CHARGING STATION	HC	TELECOMMUNICATION OUTLET "X" INDICATES TYPE	FX	FIRE ALARM VISUAL NOTIFICATION APPLIANCE - CEILING MOUNTED "XX" INDICATES CANDELA RATING IF NO RATING SHOWN, APPLIANCE IS 15cd
DL	DECORATIVE LIGHT	ACD	CEILING MOUNTED DUPLEX/QUAD RECEPTACLE OUTLET	HC	ABOVE COUNTER TELECOMMUNICATION OUTLET "X" INDICATES TYPE	FX	FIRE ALARM VISUAL NOTIFICATION APPLIANCE - CEILING MOUNTED "XX" INDICATES CANDELA RATING IF NO RATING SHOWN, APPLIANCE IS 15cd
DL	DECORATIVE LIGHT	ACD	POWER POLE	HC	TELECOMMUNICATION CEILING MOUNTED OUTLET "X" INDICATES TYPE	FX	FIRE ALARM VISUAL NOTIFICATION APPLIANCE - CEILING MOUNTED "XX" INDICATES CANDELA RATING IF NO RATING SHOWN, APPLIANCE IS 15cd
DL	DECORATIVE LIGHT	ACD	WALL/CEILING MOUNTED SPECIAL RECEPTACLE OUTLET - REFER TO ELECTRICAL STANDARD SCHEDULES	HC	TELECOMMUNICATION GROUNDING BUS BAR	FX	FIRE ALARM VISUAL NOTIFICATION APPLIANCE - CEILING MOUNTED "XX" INDICATES CANDELA RATING IF NO RATING SHOWN, APPLIANCE IS 15cd
DL	DECORATIVE LIGHT	ACD	MULTI-OUTLET SURFACE RACEWAY	HC	TELECOMMUNICATION MAIN GROUNDING BUS BAR	FX	FIRE ALARM VISUAL NOTIFICATION APPLIANCE - CEILING MOUNTED "XX" INDICATES CANDELA RATING IF NO RATING SHOWN, APPLIANCE IS 15cd
DL	DECORATIVE LIGHT	ACD	MULTI-SERVICE DROP - SEE ELECTRICAL DETAILS AND DIAGRAMS SHEET "X" INDICATES TYPE	HC	INTERROOM OUTLET	FX	FIRE ALARM VISUAL NOTIFICATION APPLIANCE - CEILING MOUNTED "XX" INDICATES CANDELA RATING IF NO RATING SHOWN, APPLIANCE IS 15cd
DL	DECORATIVE LIGHT	ACD	ACCESS FLOOR SERVICE FITTING "X" INDICATES TYPE	HC	SPEAKER	FX	FIRE ALARM VISUAL NOTIFICATION APPLIANCE - CEILING MOUNTED "XX" INDICATES CANDELA RATING IF NO RATING SHOWN, APPLIANCE IS 15cd
DL	DECORATIVE LIGHT	ACD	CORD RED "X" INDICATES TYPE	HC	SPEAKER - WALL MOUNTED	FX	FIRE ALARM VISUAL NOTIFICATION APPLIANCE - CEILING MOUNTED "XX" INDICATES CANDELA RATING IF NO RATING SHOWN, APPLIANCE IS 15cd
DL	DECORATIVE LIGHT	ACD	DUAL SWITCHING FOR INNER/OUTER LAMPS OF FLUORESCENT LIGHT FIXTURES	HC	MICROPHONE	FX	FIRE ALARM VISUAL NOTIFICATION APPLIANCE - CEILING MOUNTED "XX" INDICATES CANDELA RATING IF NO RATING SHOWN, APPLIANCE IS 15cd
DL	DECORATIVE LIGHT	ACD	3-WAY DUAL SWITCHING FOR INNER/OUTER LAMPS OF FLUORESCENT LIGHT FIXTURES	HC	VOLUME CONTROL/STATION SELECTOR	FX	FIRE ALARM VISUAL NOTIFICATION APPLIANCE - CEILING MOUNTED "XX" INDICATES CANDELA RATING IF NO RATING SHOWN, APPLIANCE IS 15cd
DL	DECORATIVE LIGHT	ACD	4-WAY DUAL SWITCHING FOR INNER/OUTER LAMPS OF FLUORESCENT LIGHT FIXTURES	HC	SIGNALING BELL	FX	FIRE ALARM VISUAL NOTIFICATION APPLIANCE - CEILING MOUNTED "XX" INDICATES CANDELA RATING IF NO RATING SHOWN, APPLIANCE IS 15cd
DL	DECORATIVE LIGHT	ACD	DIGITAL TIME SWITCH	HC	SINGLE FACE CLOCK - CEILING MOUNTED	FX	FIRE ALARM VISUAL NOTIFICATION APPLIANCE - CEILING MOUNTED "XX" INDICATES CANDELA RATING IF NO RATING SHOWN, APPLIANCE IS 15cd
DL	DECORATIVE LIGHT	ACD	ILLUMINATED TOGGLE SWITCH FOR CONTROL OF LIGHTING ON CRITICAL POWER-ILLUMINATED WHEN SWITCH IS IN "OFF" POSITION	HC	SINGLE FACE CLOCK - WALL MOUNTED	FX	FIRE ALARM VISUAL NOTIFICATION APPLIANCE - CEILING MOUNTED "XX" INDICATES CANDELA RATING IF NO RATING SHOWN, APPLIANCE IS 15cd
DL	DECORATIVE LIGHT	ACD	OCCUPANCY SENSOR - REFER TO ELECTRICAL STANDARD SCHEDULES	HC	DOUBLE FACE CLOCK - CEILING MOUNTED	FX	FIRE ALARM VISUAL NOTIFICATION APPLIANCE - CEILING MOUNTED "XX" INDICATES CANDELA RATING IF NO RATING SHOWN, APPLIANCE IS 15cd
DL	DECORATIVE LIGHT	ACD	OCCUPANCY SENSOR	HC	DOUBLE FACE COMBINATION CLOCK/SPEAKER CEILING MOUNTED	FX	FIRE ALARM VISUAL NOTIFICATION APPLIANCE - CEILING MOUNTED "XX" INDICATES CANDELA RATING IF NO RATING SHOWN, APPLIANCE IS 15cd
DL	DECORATIVE LIGHT	ACD	OCCUPANCY SENSOR "X" INDICATES TYPE	HC	DOUBLE FACE CLOCK - WALL MOUNTED	FX	FIRE ALARM VISUAL NOTIFICATION APPLIANCE - CEILING MOUNTED "XX" INDICATES CANDELA RATING IF NO RATING SHOWN, APPLIANCE IS 15cd
DL	DECORATIVE LIGHT	ACD		HC	DOUBLE FACE COMBINATION CLOCK/SPEAKER WALL MOUNTED	FX	FIRE ALARM VISUAL NOTIFICATION APPLIANCE - CEILING MOUNTED "XX" INDICATES CANDELA RATING IF NO RATING SHOWN, APPLIANCE IS 15cd
DL	DECORATIVE LIGHT	ACD		HC	CONTACTOR	FX	FIRE ALARM VISUAL NOTIFICATION APPLIANCE - CEILING MOUNTED "XX" INDICATES CANDELA RATING IF NO RATING SHOWN, APPLIANCE IS 15cd
DL	DECORATIVE LIGHT	ACD		HC	PHOTOCELL	FX	FIRE ALARM VISUAL NOTIFICATION APPLIANCE - CEILING MOUNTED "XX" INDICATES CANDELA RATING IF NO RATING SHOWN, APPLIANCE IS 15cd
DL	DECORATIVE LIGHT	ACD		HC	TWIST TIMER	FX	FIRE ALARM VISUAL NOTIFICATION APPLIANCE - CEILING MOUNTED "XX" INDICATES CANDELA RATING IF NO RATING SHOWN, APPLIANCE IS 15cd
DL	DECORATIVE LIGHT	ACD		HC	ELECTRICAL VEHICLE SUPPLY EQUIPMENT	FX	FIRE ALARM VISUAL NOTIFICATION APPLIANCE - CEILING MOUNTED "XX" INDICATES CANDELA RATING IF NO RATING SHOWN, APPLIANCE IS 15cd
DL	DECORATIVE LIGHT	ACD		HC	DC FAST CHARGER - STANDALONE	FX	FIRE ALARM VISUAL NOTIFICATION APPLIANCE - CEILING MOUNTED "XX" INDICATES CANDELA RATING IF NO RATING SHOWN, APPLIANCE IS 15cd
DL	DECORATIVE LIGHT	ACD		HC	DC FAST CHARGER - POWER MODULE	FX	FIRE ALARM VISUAL NOTIFICATION APPLIANCE - CEILING MOUNTED "XX" INDICATES CANDELA RATING IF NO RATING SHOWN, APPLIANCE IS 15cd
DL	DECORATIVE LIGHT	ACD		HC	DC FAST CHARGER - DISPENSER	FX	FIRE ALARM VISUAL NOTIFICATION APPLIANCE - CEILING MOUNTED "XX" INDICATES CANDELA RATING IF NO RATING SHOWN, APPLIANCE IS 15cd
DL	DECORATIVE LIGHT	ACD		HC	BRANCH CIRCUIT PANELBOARD	FX	FIRE ALARM VISUAL NOTIFICATION APPLIANCE - CEILING MOUNTED "XX" INDICATES CANDELA RATING IF NO RATING SHOWN, APPLIANCE IS 15cd
DL	DECORATIVE LIGHT	ACD		HC	LOAD CENTER	FX	FIRE ALARM VISUAL NOTIFICATION APPLIANCE - CEILING MOUNTED "XX" INDICATES CANDELA RATING IF NO RATING SHOWN, APPLIANCE IS 15cd
DL	DECORATIVE LIGHT	ACD		HC	MULTI CHANNEL METER	FX	FIRE ALARM VISUAL NOTIFICATION APPLIANCE - CEILING MOUNTED "XX" INDICATES CANDELA RATING IF NO RATING SHOWN, APPLIANCE IS 15cd
DL	DECORATIVE LIGHT	ACD		HC	MOTOR CONTROL CENTER	FX	FIRE ALARM VISUAL NOTIFICATION APPLIANCE - CEILING MOUNTED "XX" INDICATES CANDELA RATING IF NO RATING SHOWN, APPLIANCE IS 15cd
DL	DECORATIVE LIGHT	ACD		HC	TRANSFORMER	FX	FIRE ALARM VISUAL NOTIFICATION APPLIANCE - CEILING MOUNTED "XX" INDICATES CANDELA RATING IF NO RATING SHOWN, APPLIANCE IS 15cd
DL	DECORATIVE LIGHT	ACD		HC	DISTRIBUTION EQUIPMENT	FX	FIRE ALARM VISUAL NOTIFICATION APPLIANCE - CEILING MOUNTED "XX" INDICATES CANDELA RATING IF NO RATING SHOWN, APPLIANCE IS 15cd
DL	DECORATIVE LIGHT	ACD		HC	ELECTRICAL GROUNDING BUS BAR	FX	FIRE ALARM VISUAL NOTIFICATION APPLIANCE - CEILING MOUNTED "XX" INDICATES CANDELA RATING IF NO RATING SHOWN, APPLIANCE IS 15cd
DL	DECORATIVE LIGHT	ACD		HC	PLUG IN BUSWAY	FX	FIRE ALARM VISUAL NOTIFICATION APPLIANCE - CEILING MOUNTED "XX" INDICATES CANDELA RATING IF NO RATING SHOWN, APPLIANCE IS 15cd
DL	DECORATIVE LIGHT	ACD		HC	FEEDER BUSWAY	FX	FIRE ALARM VISUAL NOTIFICATION APPLIANCE - CEILING MOUNTED "XX" INDICATES CANDELA RATING IF NO RATING SHOWN, APPLIANCE IS 15cd
DL	DECORATIVE LIGHT	ACD		HC	CABLE TRAY - ALL SIZES IN INCHES	FX	FIRE ALARM VISUAL NOTIFICATION APPLIANCE - CEILING MOUNTED "XX" INDICATES CANDELA RATING IF NO RATING SHOWN, APPLIANCE IS 15cd

STANDARD MOUNTING HEIGHTS

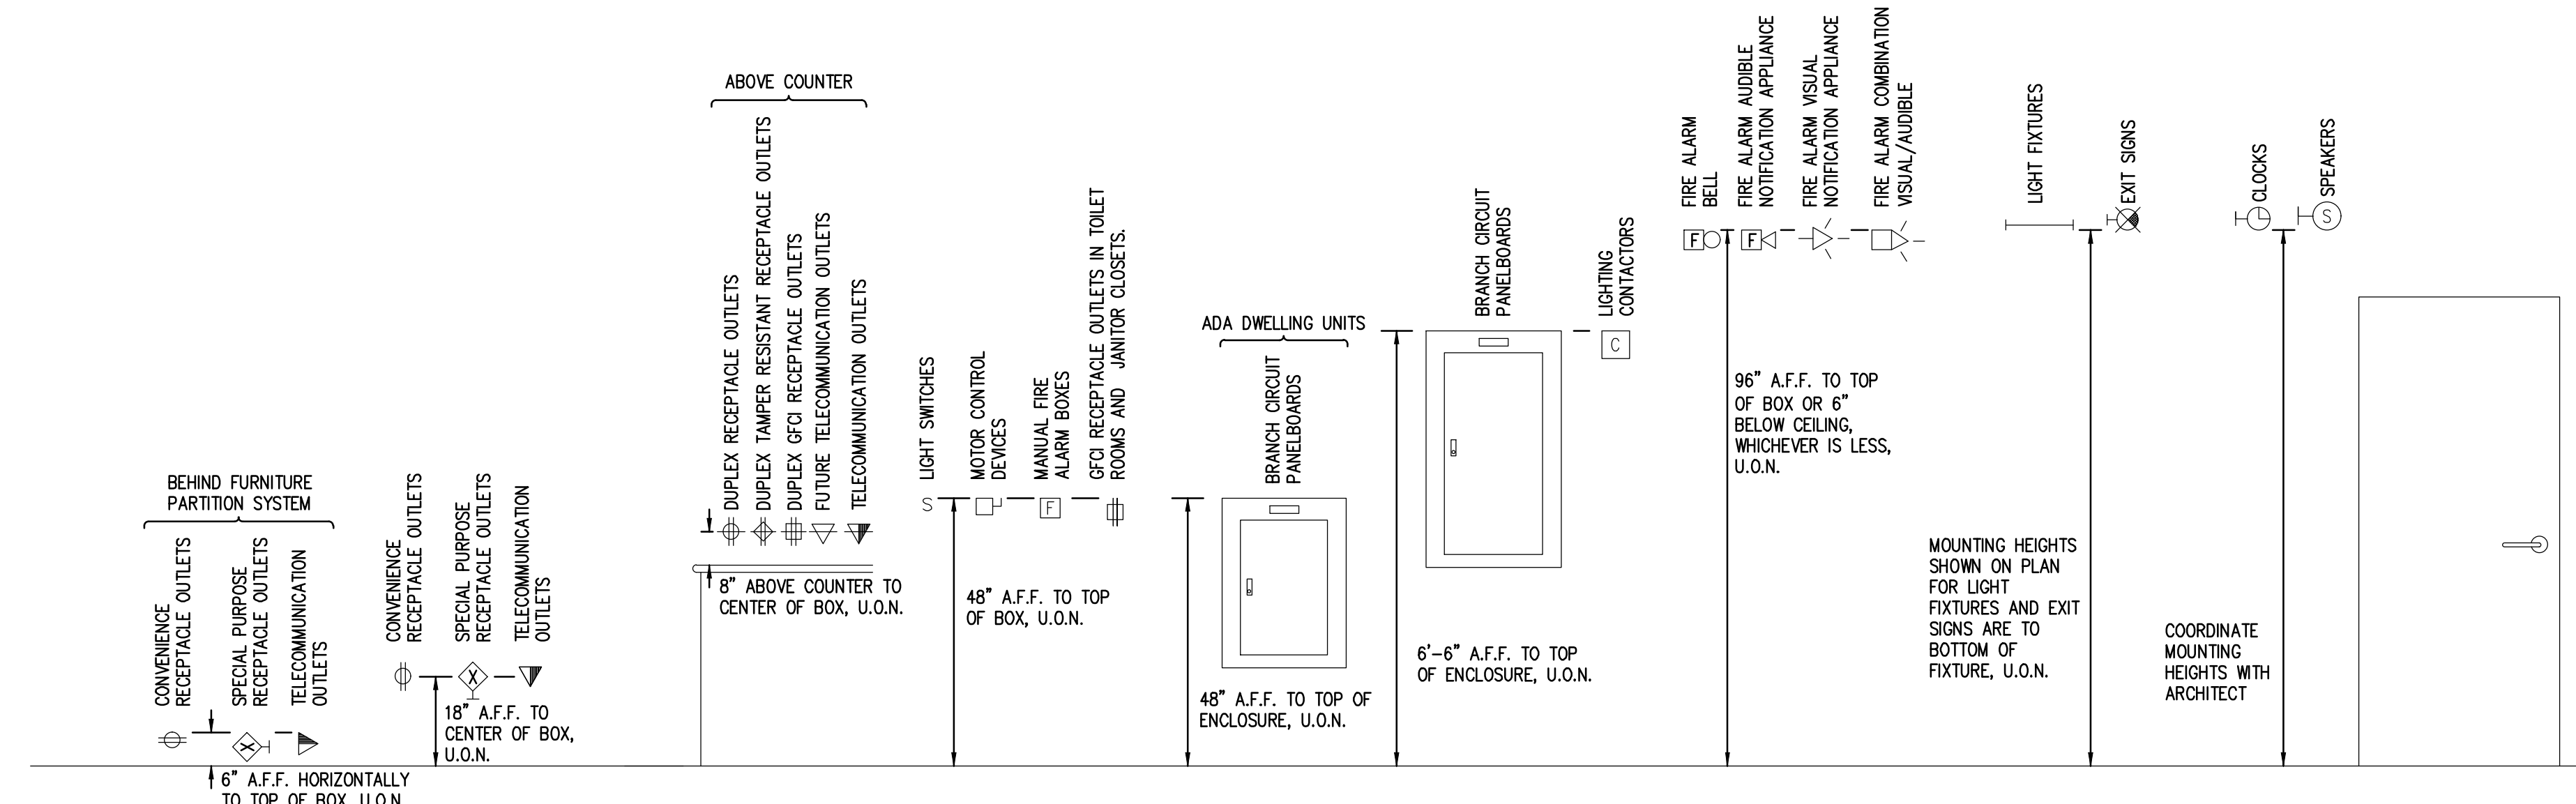


ELECTRICAL DRAWING INDEX

SHEET NO.	SHEET TITLE
E-01	ELECTRICAL STANDARDS AND DRAWING INDEX
E-02	ELECTRICAL STANDARD SCHEDULES
E-03	ELECTRICAL SITE PLAN


ELECTRICAL ABBREVIATION LIST

ABBREVIATION	DESCRIPTION	ABBREVIATION	DESCRIPTION	ABBREVIATION	DESCRIPTION
A	AMPERES	G/SRD/EG	GROUND	OC	ON CENTER
AER	ARC ENERGY REDUCTION	GFCI	GROUND FAULT CIRCUIT INTERRUPTER	OFCI	OWNER FURNISHED, CONTRACTOR INSTALLED
AF	AMPERES FRAME (BREAKER RATING)	GFI	GROUND FAULT PROTECTION	OFI	OWNER FURNISHED, OWNER INSTALLED
AFO	ARC FAULT CIRCUIT INTERRUPTER	HOA	HAND-OFF-AUTO	OFI	OWNER FURNISHED, OWNER INSTALLED
A.F.F.	ABOVE FINISH FLOOR	HP	HORSEPOWER	P	POLE
AIC	AMPS INTERRUPTING CAPACITY	HZ	HERTZ	PB	PUSHBUTTON STATION
AL	AUDIENCE LEFT	IG	ISOLATED GROUND	PH	PHASE
ALR	AUTOMATIC LOAD CONTROL RELAY	IB	JUNCTION BOX	PT	POTENTIAL TRANSFORMER
AR	AUDIENCE RIGHT	JB	JUNCTION BOX	POP	POWER DISTRIBUTION PANEL
AT	AMPERES TRIP (BREAKER SETTING)	KA	THOUSAND AMP	RECEPT.	RECEPTACLE
ATS	AUTOMATIC TRANSFER SWITCH	KV	KILOVOLT	RDP	RECEPTACLE DISTRIBUTION PANEL
AUX	AUXILIARY	KVA	KILOVOLT - AMPERES	RIP	RECEPTACLE DISTRIBUTION PANEL
BELTS	BRANCH CIRCUIT EMERGENCY LIGHTING TRANSFER SWITCH	KW	KILOWATT	RSC	RIGID STEEL CONDUIT
BKR	BREAKER	KWH	KILOWATT - HOURS	SCCR	SHORT CIRCUIT CURRENT RATING
BPS	BOLTED PRESSURE SWITCH	LA	LIGHTNING ARRESTOR	SCHED	SCHEDULE
C	CONDUIT	LP	LIGHTING PANEL	SPD	SURGE PROTECTION DEVICE
CB	CIRCUIT BREAKER	LDP	LIGHTING DISTRIBUTION PANEL	ST	SHUNT TRIP
CFO	CONTRACTOR FURNISHED, CONTRACTOR INSTALLED	MAX	MAXIMUM	SWB	SWITCHBOARD
CKT	CIRCUIT	MCA	MINIMUM CIRCUIT AMPACITY	SWGR	SWITCHGEAR
CT	CURRENT TRANSFORMER	MCB	MAIN CIRCUIT BREAKER	TB	TERMINAL BOX
DEMO	DEMOLITION	MCC	MAIN CONTROL CENTER	TELECOM	TELECOMMUNICATIONS
DEM	DIMENSION	MCP	MAIN DISTRIBUTION PANEL	TR	TAMPER RESISTANT
DISC	DISCONNECT	MCH	MECHANICAL	TTB	TELEPHONE TERMINAL BACKBOARD
DP	DISTRIBUTION PANEL	MIN	MINIMUM	TYP	TYPICAL
DS	DOWNSTAGE	MISC.	MISCELLANEOUS	U.O.N.	UNLESS OTHERWISE NOTED
DWG	DRAWING	MLO	MAIN LUGS ONLY	UVR	UNDERVOLTAGE RELEASE
EBU	EMERGENCY BATTERY UNIT	MOP	MAXIMUM OVERCURRENT PROTECTION	US	UPSTAGE
EC	ELECTRICAL CONTRACTOR	MTD	MOUNTED	V	VOLTS
EDM	ELECTRONICALLY COMMUTATED MOTOR	MTG	MOUNTING	W	WIRE OR WATTS
ELEC	ELECTRICAL	MTR	MOTOR	WAP	WIRELESS ACCESS POINT
EM/EMERG	EMERGENCY	N	NEUTRAL	WG	WIRE GUARD
EMT	ELECTRICAL METALLIC TUBING	NC	NORMALLY CLOSED	WP	WEATHERPROOF
EO	ELECTRICALLY OPERATED	NEC	NATIONAL ELECTRICAL CODE	WR	WEATHER RESISTANT
EPO	EMERGENCY POWER OFF	NF	NON-FUSIBLE	XPMR	TRANSFORMER HOMERUN
EWG	ELECTRIC WATER COOLER	NT	NOT IN CONTRACT	XP	EXPLOSION PROOF
EXST	EXISTING	NC	NIGHT LIGHT	(E)	EXISTING
FA	FIRE ALARM	NO	NORMALLY OPEN	(R)	RELOCATED
FLA	FULL LOAD AMPS	NTS	NOT TO SCALE		
FLR	FLOOR				
FHM	FRONT OF HOUSE				
FSEC	FOOD SERVICE EQUIPMENT CONTRACTOR				
FU	FUSE				

STANDARD METHODS OF NOTATION

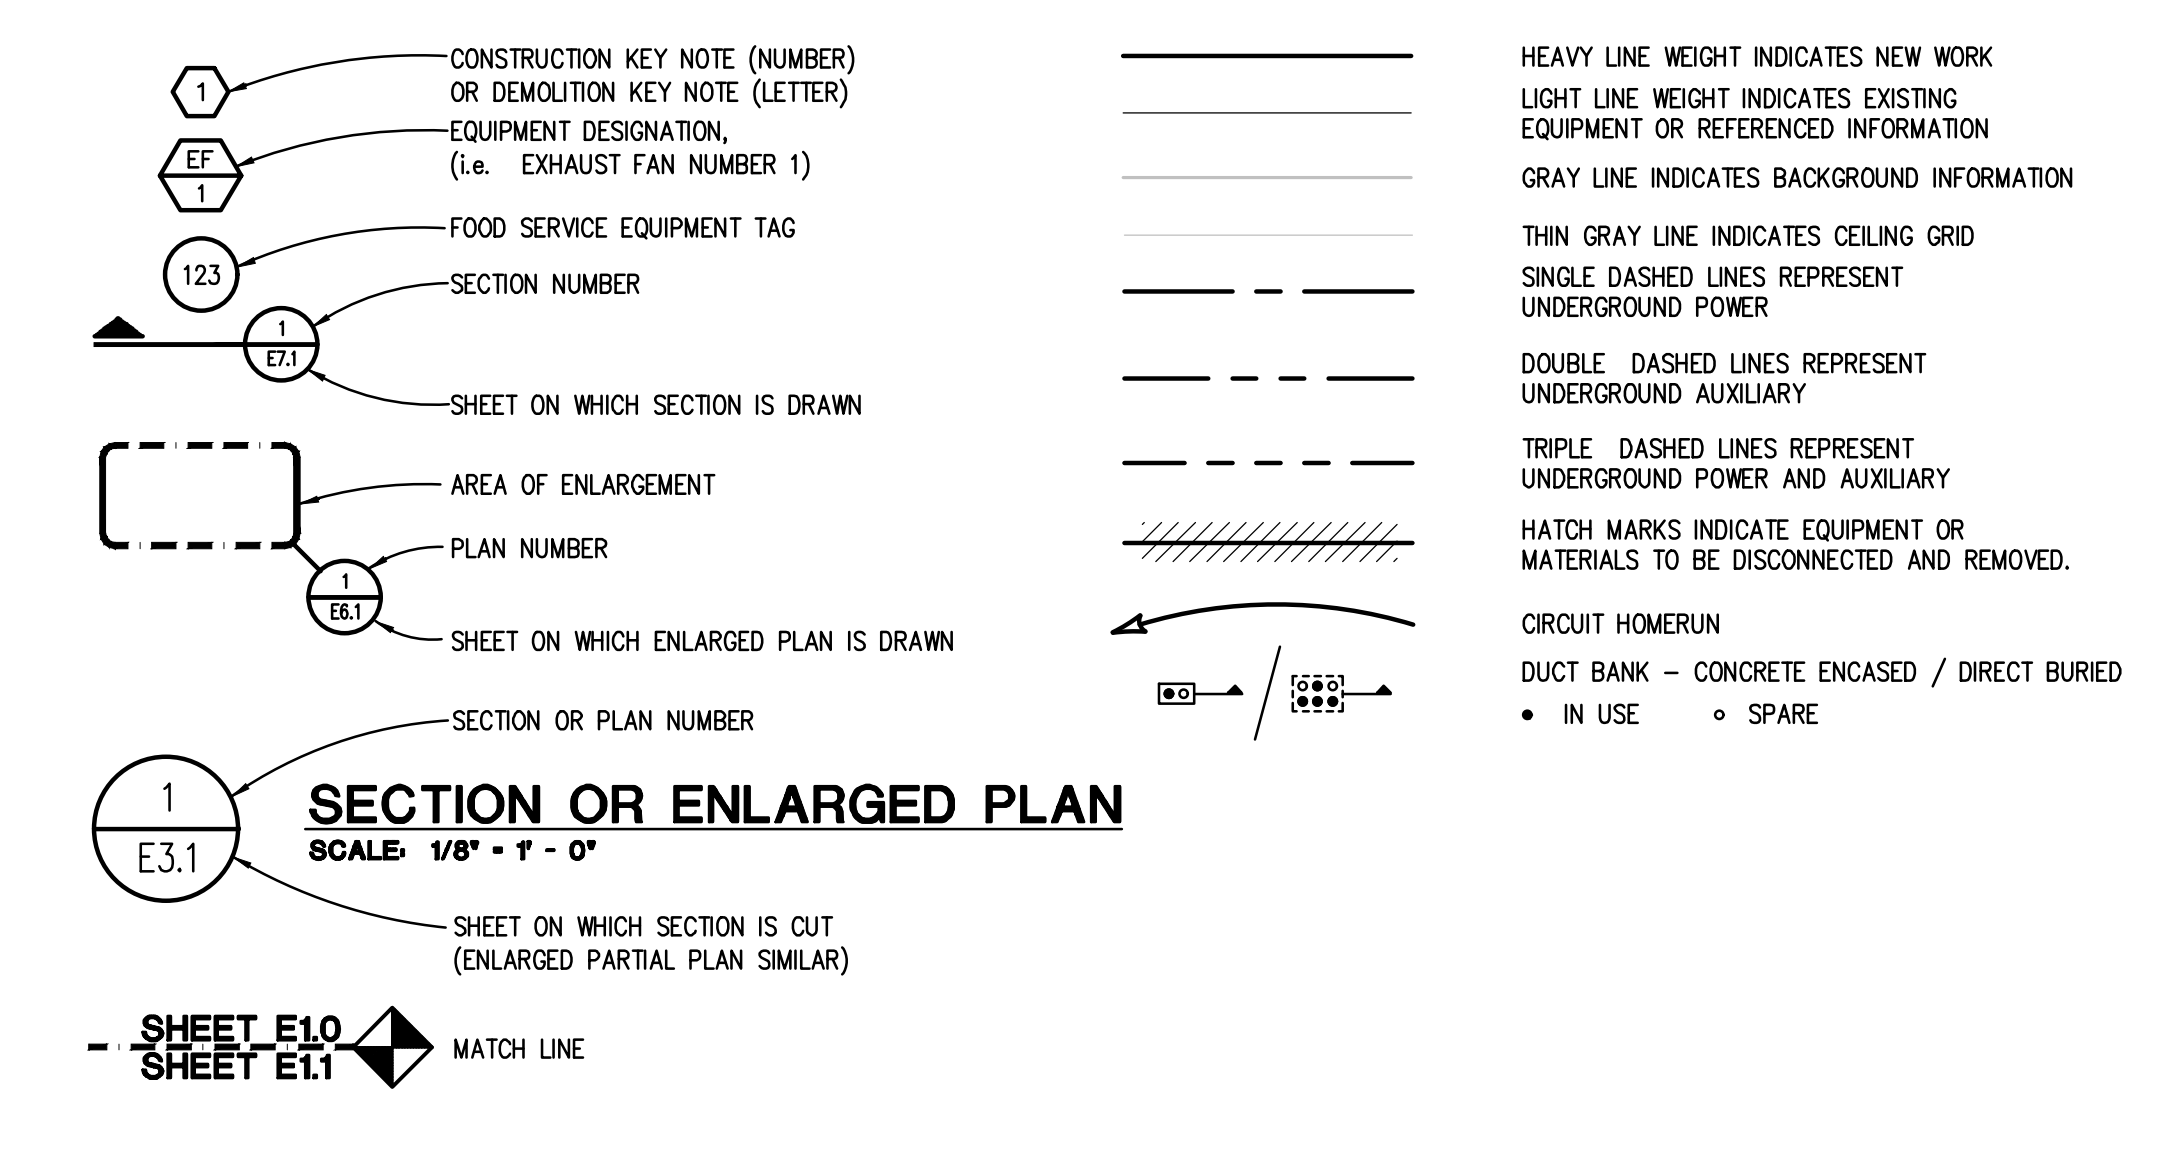

SECTION OR ENLARGED PLAN
SCALE: 1/8" = 1' - 0"

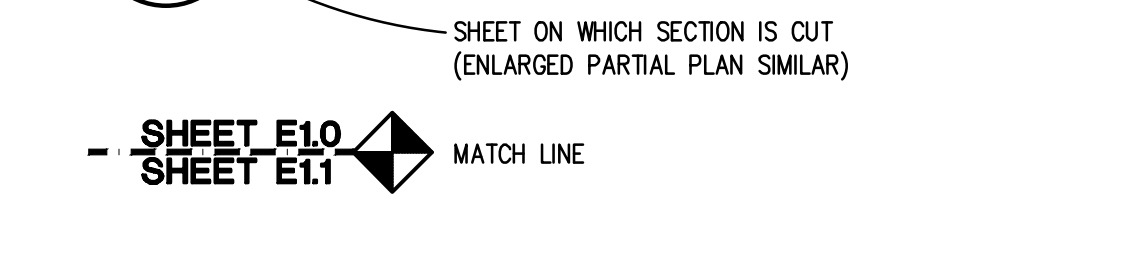

C:\2021\2021-0178-00\CAD\51 Parking Structure Walks PH2\2021-0178-51-EO-IND.dwg, E-01, 5/26/2026 11:23:03 AM, Aubrey N. Taylor, Peter Basso Associates Inc.

REVISION

REVISION

5145 Livemore, Suite 100
Tel: 286-879-5596 Fax: 286-879-2007
www.PeterBassoAssociates.com
PBA Project No. 2021.0178.01

Peter Basso Associates Inc
CONSULTING ENGINEERS

Washtenaw
Community College

 
PROJECT TITLE
WASHTENAW COMMUNITY COLLEGE
CW WALKWAY LIGHTING PROJECT
Parking and Interior Walkways - Phase 2
Ann Arbor, MI

SHEET TITLE
ELECTRICAL STANDARDS AND
DRAWING INDEX



DATE
05/26/2026
ISSUE
BIDS
SHEET No.

E-01

THE FOLLOWING DIMENSION EQUALS ONE INCH WHEN PRINTED TO SCALE.



E. HURON RIVER DR

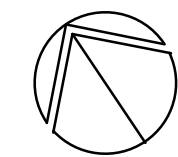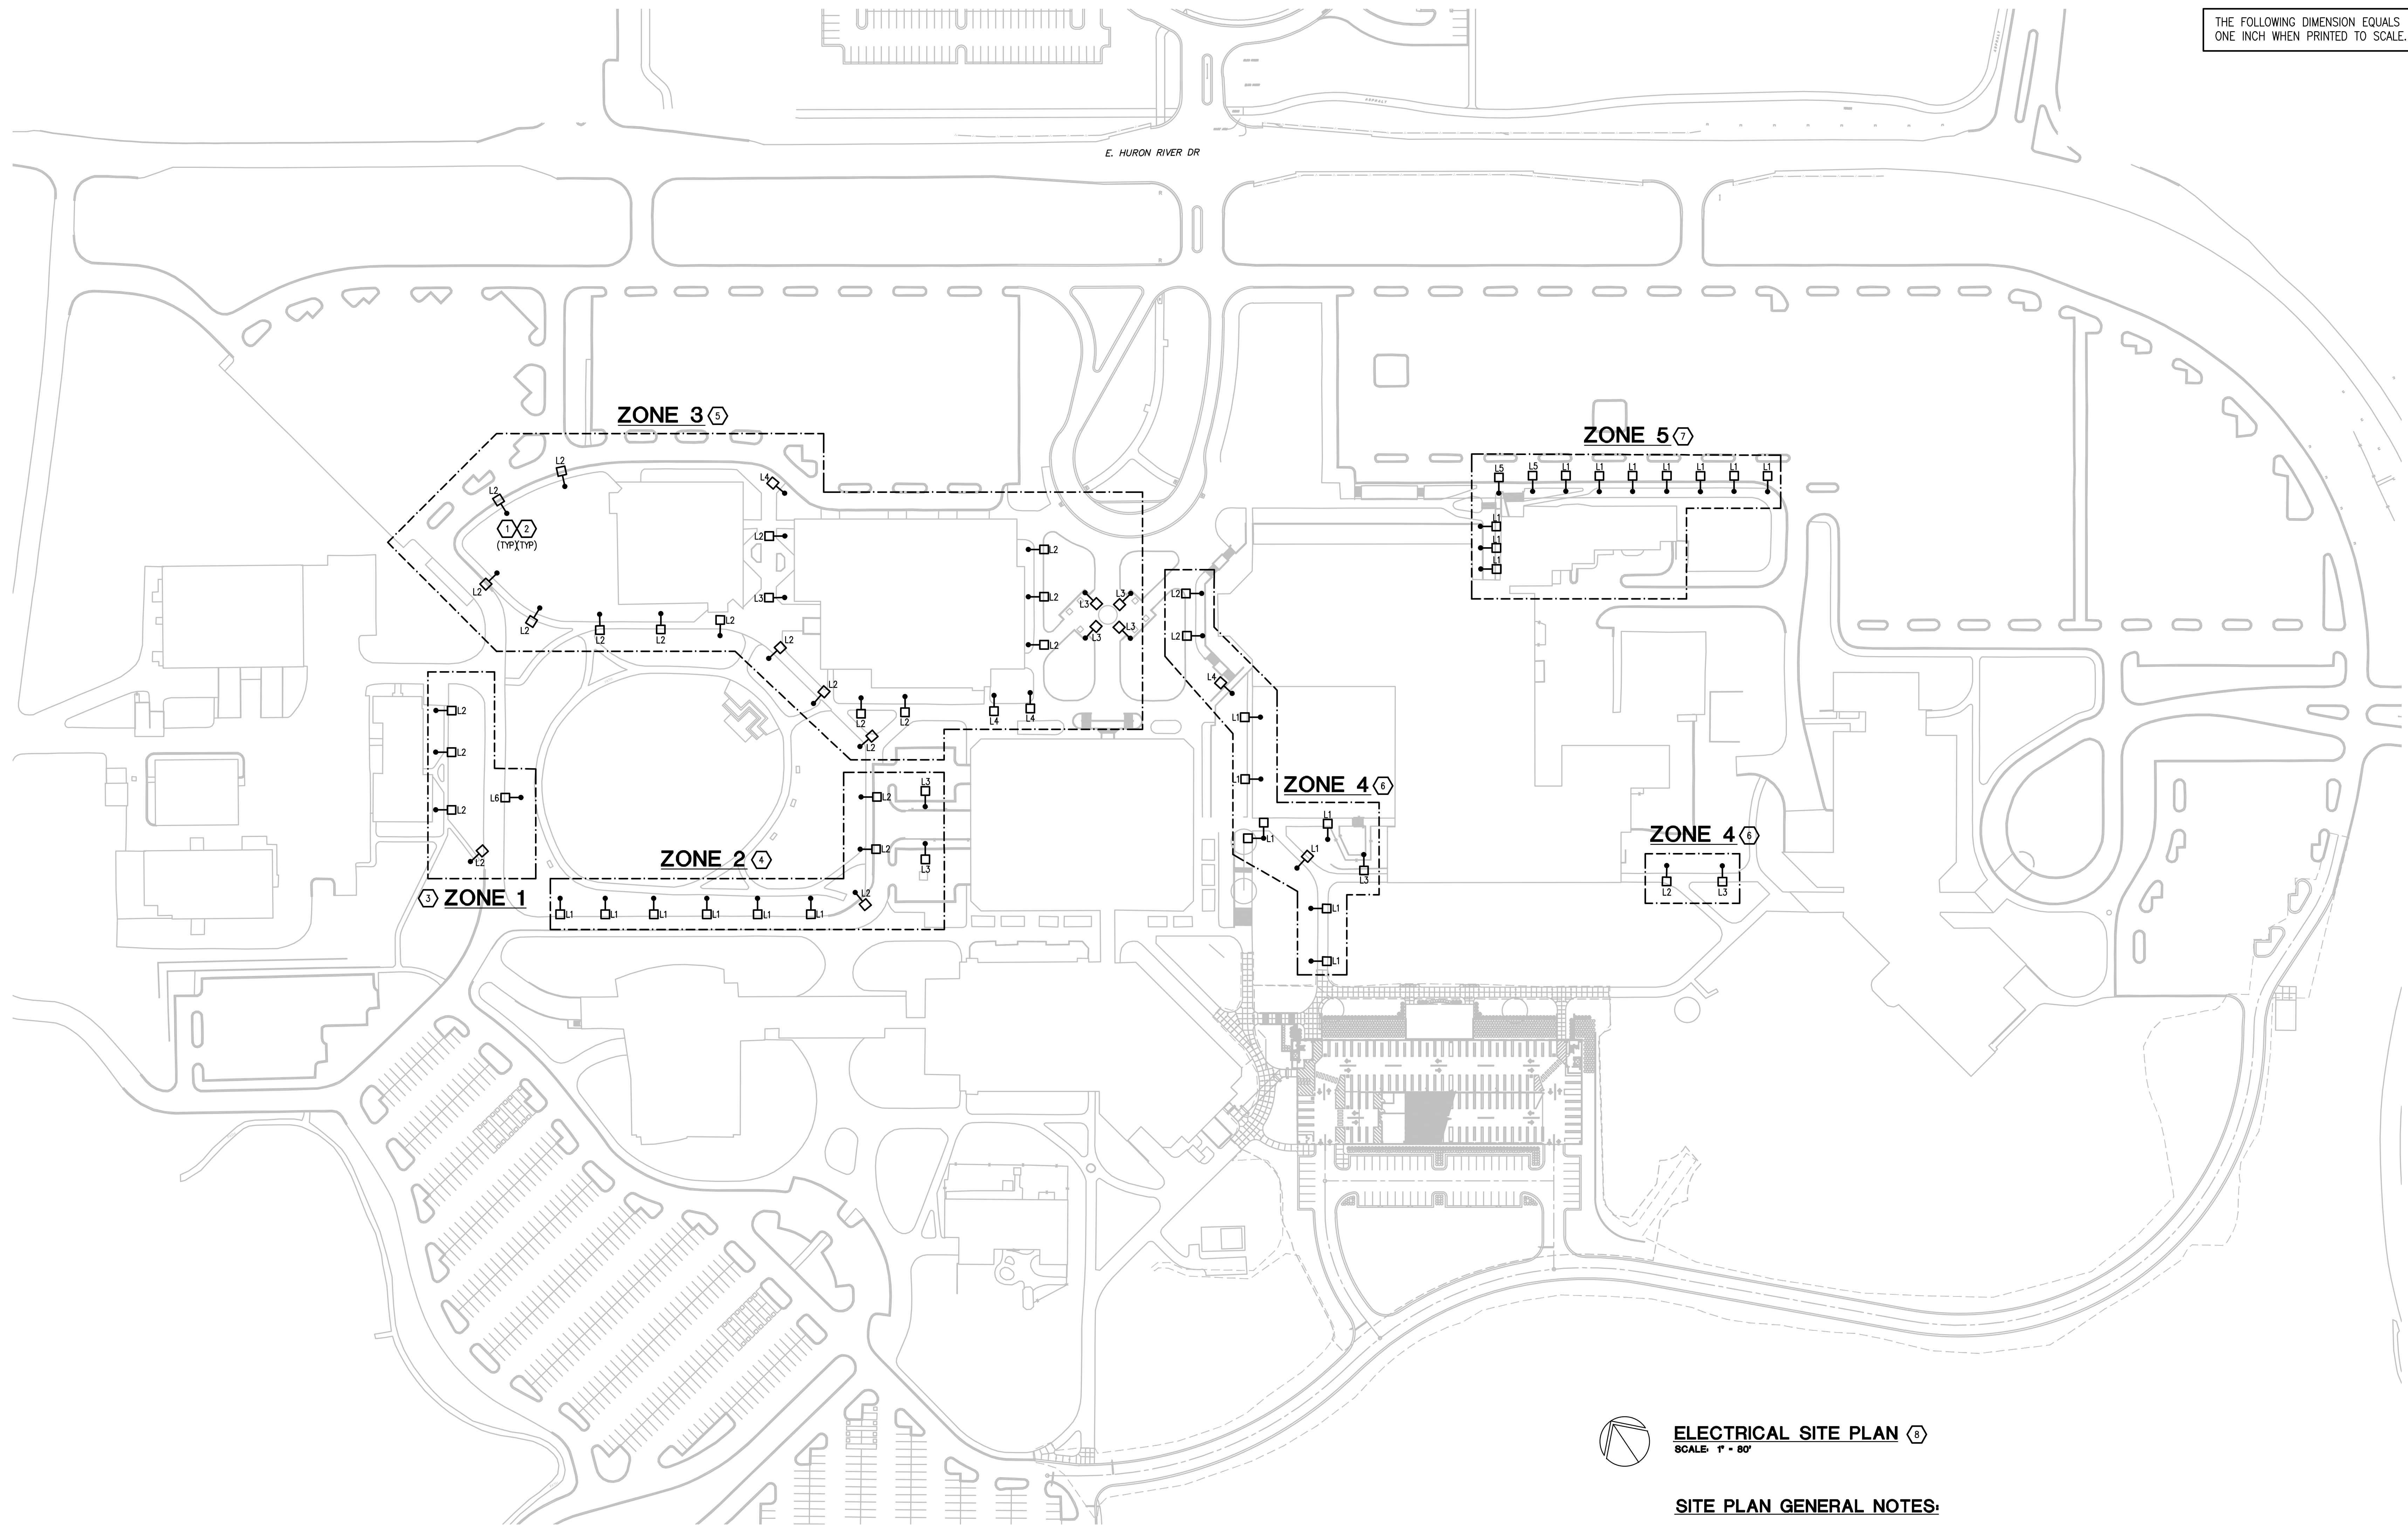

ELECTRICAL SITE PLAN

SCALE: 1" = 80'

SITE PLAN GENERAL NOTES:

1. THESE NOTES ARE GENERIC GUIDELINES ONLY. ELECTRICAL CONTRACTOR'S PERSONNEL ON SITE SHALL BE THOROUGHLY FAMILIAR WITH THE PUBLISHED SPECIFICATIONS FOR EXACT DESCRIPTIONS OF SCOPE, METHODS, AND MATERIAL.
2. THESE DRAWINGS REPRESENT THE GENERAL EXTENT AND ARRANGEMENT OF SYSTEMS. COORDINATE EXACT EQUIPMENT LOCATIONS, ELEVATIONS, AND FINAL CONNECTION REQUIREMENTS. PROVIDE EACH SYSTEM COMPLETE, INCLUDING ALL NECESSARY COMPONENTS, FITTINGS AND OFFSETS.

CONSTRUCTION KEY NOTES:

1. REMOVE EXISTING LIGHT FIXTURE. INSTALL NEW LED FIXTURE ON EXISTING LIGHTING POLE. PROVIDE UNIVERSAL MOUNT FOR LIGHT FIXTURE. RE-USE EXISTING WIRING. FIELD CONFIRM EXISTING VOLTAGE PRIOR TO PURCHASE. PROVIDE FUSES IN LIGHT POLE. BYPASS EXISTING LIGHTING CONTROLS.
2. LIGHT FIXTURES TO BE CONTROLLED VIA EXISTING NIGHT ECLIPSE CONTROLLERS. PROVIDE ALL NIGHT AIR LIGHTING CONTROL SYSTEM MANUFACTURER PROGRAMMING AND COMMISSIONING FOR A COMPLETE AND FUNCTIONAL SYSTEM. REFER TO SEQUENCE OF OPERATION FOR MORE INFORMATION.
3. LIGHTING IN ZONE 1 IS TO BE CONTROLLED VIA EXISTING N-LIGHT ECLIPSE CONTROLLER IN DAMON FLOWERS BUILDING.
4. LIGHTING IN ZONE 2 IS TO BE CONTROLLED VIA EXISTING N-LIGHT ECLIPSE CONTROLLER IN GUNDER MYRON.
5. LIGHTING IN ZONE 3 IS TO BE CONTROLLED VIA EXISTING N-LIGHT ECLIPSE CONTROLLER IN BUSINESS EDUCATION BUILDING.
6. LIGHTING IN ZONE 4 IS TO BE CONTROLLED VIA EXISTING N-LIGHT ECLIPSE CONTROLLER IN PARKING STRUCTURE.
7. LIGHTING IN ZONE 5 IS TO BE CONTROLLED VIA EXISTING N-LIGHT ECLIPSE CONTROLLER IN GREAT LAKES TRAINING CENTER.
8. REMOVE EXISTING CRESTON EXTERIOR LIGHTING CONTROLLERS FROM CAMPUS.



Know what's below.
Call before you dig.

REVISION
05/16/2025
ADDENDUM 2

5145 Livernois, Suite 100
Farmington Hills, MI 48334
Tel: 248-879-5566 Fax: 248-879-0007
www.PeterBassoAssociates.com
PBA Project No. 2022017004

Peter Basso Associates Inc
CONSULTING ENGINEERS

Washtenaw
Community College

PROJECT TITLE
WASHTENAW COMMUNITY COLLEGE
CW WALKWAY LIGHTING PROJECT
Parking and Interior Walkways - Phase 2
Ann Arbor, MI

SHEET TITLE
ELECTRICAL SITE PLAN
DATE
05/26/2026
ISSUE
BIDS

SHEET No.
E-0.3

G:\2021\2021-0178-00\CAD\51 Parking Structure Walks PH2\2021-0178-51-EC-SPN.dwg, E-0.3, 5/26/2026 11:23:14 AM, Aubrey N. Taylor, Peter Basso Associates, Inc.